


- FOUL NOTES.**
1. ALL FOUL PIPES TO BE uPVC AND SHALL COMPLY WITH THE PROVISIONS IS EN 1401 2009/2012. PIPES TO BE APPLICATION AREA CODE "UD", STIFFNESS CLASS 8kN/m² (SN8).
 2. ALL GULLIES AND MANHOLES THAT WILL BE IN CHARGE MUST BE AS PER IRISH WATER STANDARD DETAILS.
 3. ALL POP UP SIZES TO BE 100mmØ UNLESS OTHERWISE STATED. NOTE POP UP SIZES AND LOCATION AS RECEIVED BY OTHERS.
 4. REMOVAL OF EXISTING TREES AND VEGETATION, IN LINE WITH NPWS GUIDELINES.
 5. ALL DRAIN AND SERVICE CONNECTION PIPEWORK TO BE IN ACCORDANCE WITH IRISH WATER STANDARD DETAIL STD-WW-03.
 6. PRIOR TO COMMENCEMENT OF DEVELOPMENT ALL OUTFALL CONNECTION INVERT LEVELS TO BE CONFIRMED.

- STORM NOTES.**
1. ALL STORM PIPES TO BE CONCRETE WITH SPIGOT, SOCKET JOINTS AND RUBBER RINGS FITTINGS TO COMPLY WITH IS EN 1916 AND IS 6 2004 OR EQUIVALENT STANDARD. CLASS M OR CLASS H.
 2. ALL GULLIES AND MANHOLES MUST BE EITHER BLOCKWORK OR CAST INSITU.
 3. ALL GULLY CONNECTIONS TO BE 150mmØ CLAY UNLESS STATED OTHERWISE.
 4. REMOVAL OF EXISTING TREES AND VEGETATION, IN LINE WITH NPWS GUIDELINES.
 5. PRIOR TO COMMENCEMENT OF DEVELOPMENT ALL OUTFALL CONNECTION INVERT LEVELS TO BE CONFIRMED.

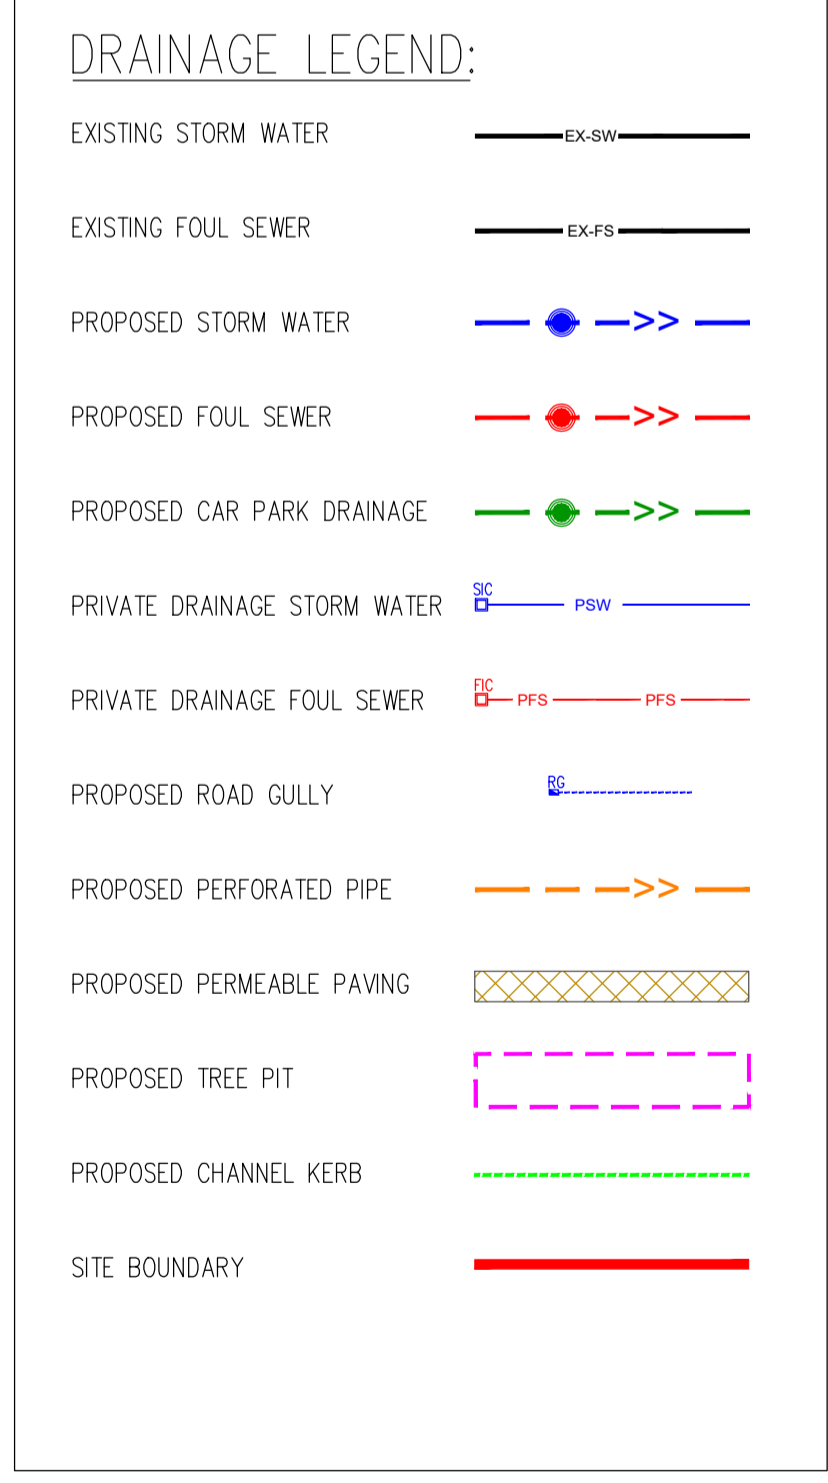

BLOCK 4.
FUTURE PERMITTED SCHEME.
DCC PLANNING REF: 305319.

BLOCK 13.
FUTURE PERMITTED SCHEME.
DCC PLANNING REF: 3894/19.

PLANNING DRAWING.
NOT FOR CONSTRUCTION.
ALL LEVELS GIVEN ARE
RELATIVE TO ORDNANCE DATUM.
THIS DRAWING HAS BEEN ISSUED FOR INFORMATION
PURPOSES ONLY AND MUST NOT BE USED
FOR CONSTRUCTION UNDER ANY CIRCUMSTANCES

NOTES

1. For setting out refer to Architect's drawings.
2. This drawing to be read in conjunction with all other Architectural and Engineering drawings and all other relevant drawings and Specifications.
3. DO NOT SCALE THIS DRAWING. Use figured dimensions only.
4. No part of this document may be reproduced or transmitted in any form or stored in any retrieval system of any nature without the written permission as copyright holder except as agreed for use on the project for which the document was originally issued.
5. Ordnance Survey Ireland Licence Number EN 0074024

Rev. No.	Date	REVISION NOTE	Drn. By	Chkd. By
P1	16.05.2024	ISSUED FOR STAGE 2 PLANNING	JF	GL
P2	28.06.2024	ISSUED FOR STAGE 3 PLANNING	JS	JF
P3	23.07.2024	ISSUED FOR REVIEW	JS	JF
P4	08.08.2024	ISSUED FOR REVIEW	JF	GF
P5	13.08.2024	ISSUED FOR PLANNING SUBMISSION	JS	GF

Client	Project	Title	Dwg. No.	Date	Drn. By	Chkd. By	Aprvd. By	Scale	Revision
LDA	Clongriffin Blocks 5 & 6	Proposed Drainage Layout Sheet 2 of 2	CLN-CSC-XX-XX-DR-C-0112	MAY 2024	JS	JF	NB	1:250 @ A1	P5

Client	Project	Title	Dwg. No.	Date	Drn. By	Chkd. By	Aprvd. By	Scale	Revision
LDA	Clongriffin Blocks 5 & 6	Proposed Drainage Layout Sheet 2 of 2	CLN-CSC-XX-XX-DR-C-0112	MAY 2024	JS	JF	NB	1:250 @ A1	P5

CS Consulting Group
DUBLIN | LONDON | LIMERICK

Head Office
19-22 Dame Street, Dublin 2.
T: +353 (0)1 5480863
e: info@csconsulting.ie
w: www.csconsulting.ie

Quality Environment I.S. EN ISO 9001:2008
NSAI Certified I.S. EN ISO 14001:2004
Health & Safety I.S. EN ISO 50001:2011
OHSAS 18001:2007